



# VIJAYA INSTITUTE OF PHARMACEUTICAL SCIENCES FOR WOMEN

Permitted by Govt. of A.P; Approved by AICTE, New Delhi  
Pharmacy Council of India, New Delhi & Affiliated to JNTUK, Kakinada  
**ISO 9001:2015 Certified Institution**


Enikepadu, VIJAYAWADA – 521108

Telephone No: +91 74165 60999

Fax No: +91 866 2844999

Mail: vijayapharmacyfw@gmail.com

## MAINTENANCE OF WATER BODIES AND DISTRIBUTION SYSTEMS

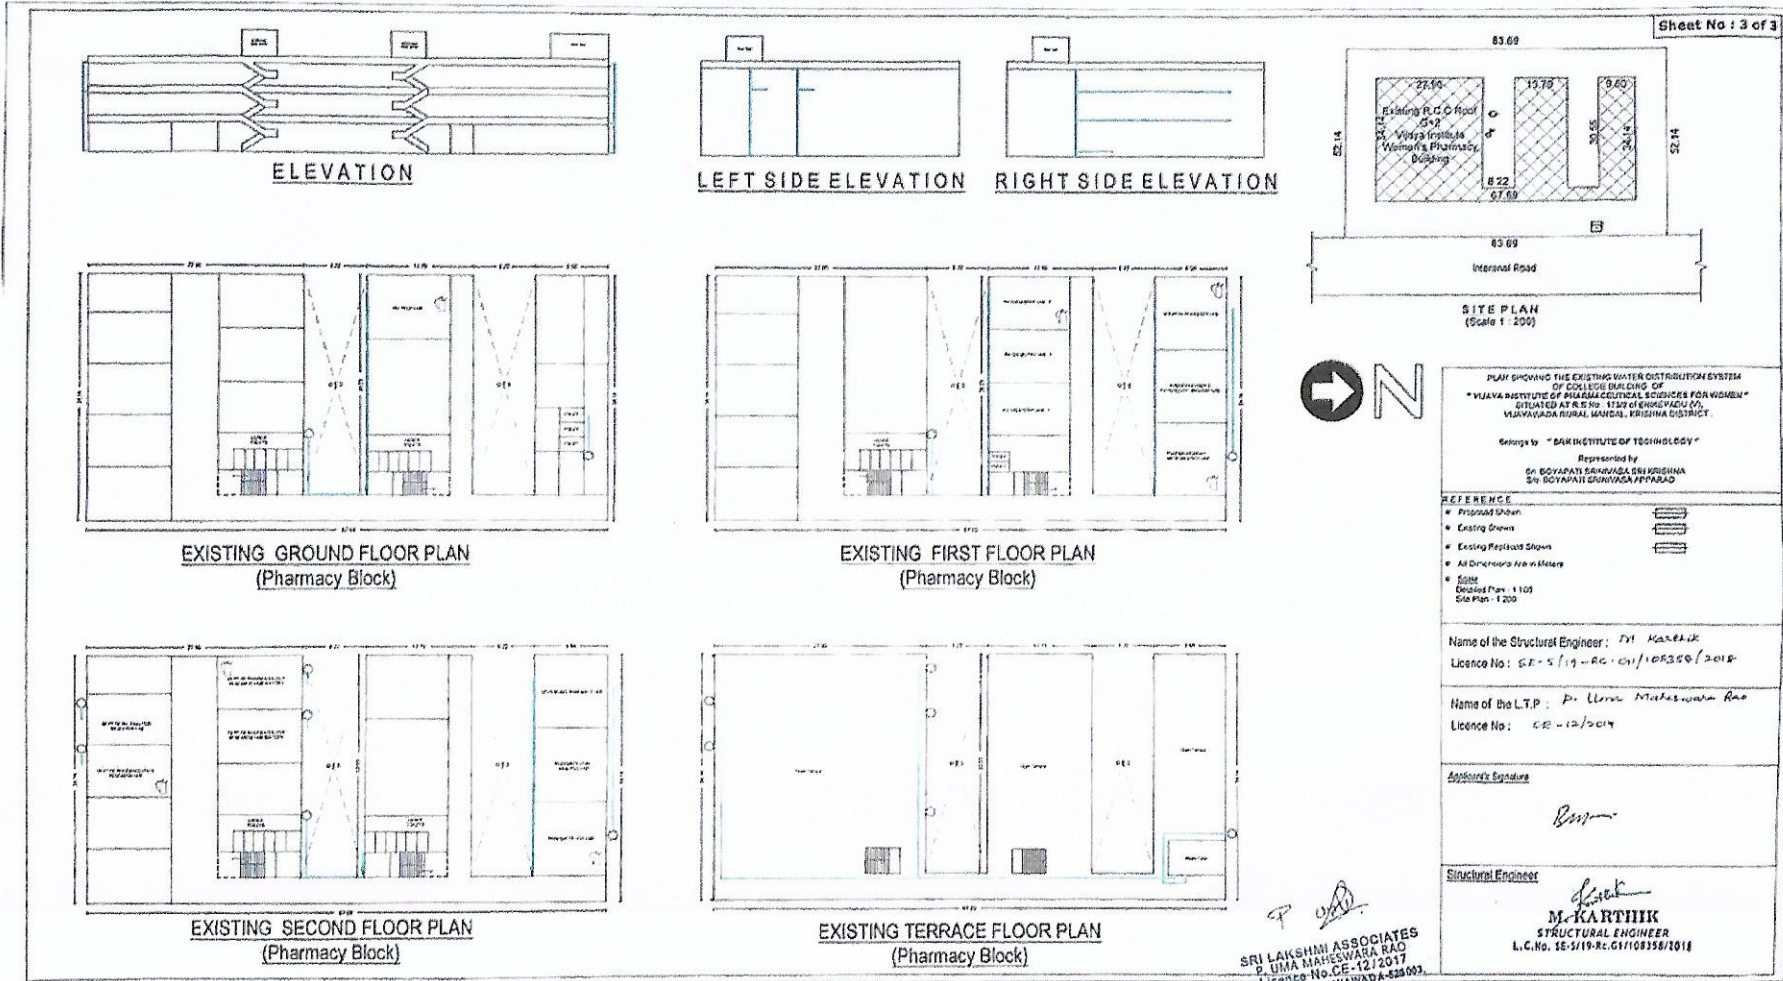

Sheet No : 3 of 3

**SITE PLAN**  
(Scale 1 : 200)

Internal Road

PLAN SHOWING THE EXISTING WATER DISTRIBUTION SYSTEM OF COLLEGE BUILDING OF  
"VIJAYA INSTITUTE OF PHARMACEUTICAL SCIENCES FOR WOMEN"  
SITUATED AT R.R. NO. 11ST OF ENIKEPADU (P),  
VIJAYAWADA RURAL MANDAL, KRISHNA DISTRICT.

Group to "BANK INSTITUTE OF TECHNOLOGY"

Represented by  
Sri GOVAPATI SRINIVASA SRI KRISHNA  
Sri GOVAPATI SRINIVASA APPARAO

**REFERENCE**

- Proposed Showin
- Existing Showin
- Existing Postcast Showin
- All Dimension Area in Metere
- Scale  
Detailed Plan - 1:100  
Site Plan - 1:200


Name of the Structural Engineer: **Dr. KANESHK**  
Licence No: SE-5/19-RC-G1/108358/2018

Name of the L.T.P.: **P. Umm. Maheswara Rao**  
Licence No: CE-12/2014

Author's Signature  
*[Signature]*

Structural Engineer  
*[Signature]*  
**Dr. KANESHK**  
STRUCTURAL ENGINEER  
L.C.No. SE-5/19-RC-G1/108358/2018

SRI LAKSHMI ASSOCIATES  
P. UMA MAHESWARA RAO  
Licence No. CE-12/2017  
Gandhinagar, VIJAYAWADA-521003.  
Ph. 9701002886

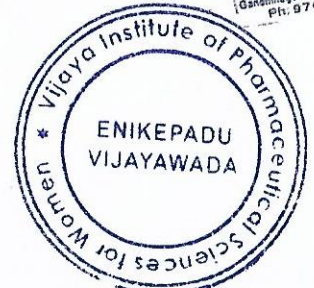

*[Signature]*  
**PRINCIPAL**  
**VIJAYA INSTITUTE**  
**PHARMACEUTICAL SCIENCES FOR WOMEN**  
**ENIKEPADU VIJAYAWADA 521108**